


TY77008	IV20X3	(19)
TY8112B	IV20X6	(25)
HY7014C	CVS1.25a-2C	(25)
IV20X3		
VV5110a	IV20X6	(25)
MY6040	IV20X6	(25)
PVY	IV20X2	(18)
WM	IV20X2E2a	(19)

①	CVV51.25a-2C	(19)
②	CVV51.25a-2CX3	(31)
③	IV20X4	(25)
④	CVV51.25a-2C	(25)
	CVV51.25a-3C	(25)

RB	CVV51.25a-3C	(PF16)
WY7812	CVV51.25a-2C	(PF16)
VV5110	IV20X3	(18)
M7410	IV20X3	(18)

名称	福祉のまちづくり工学研究所空調設備工事					
題名	空調設備(自動制御)2階平面図					
図番	年月日	縮尺	承認	検印	製図	設計
M-22	1996.9.	1/100		上項	黒田	
恒 菱 株式会社						

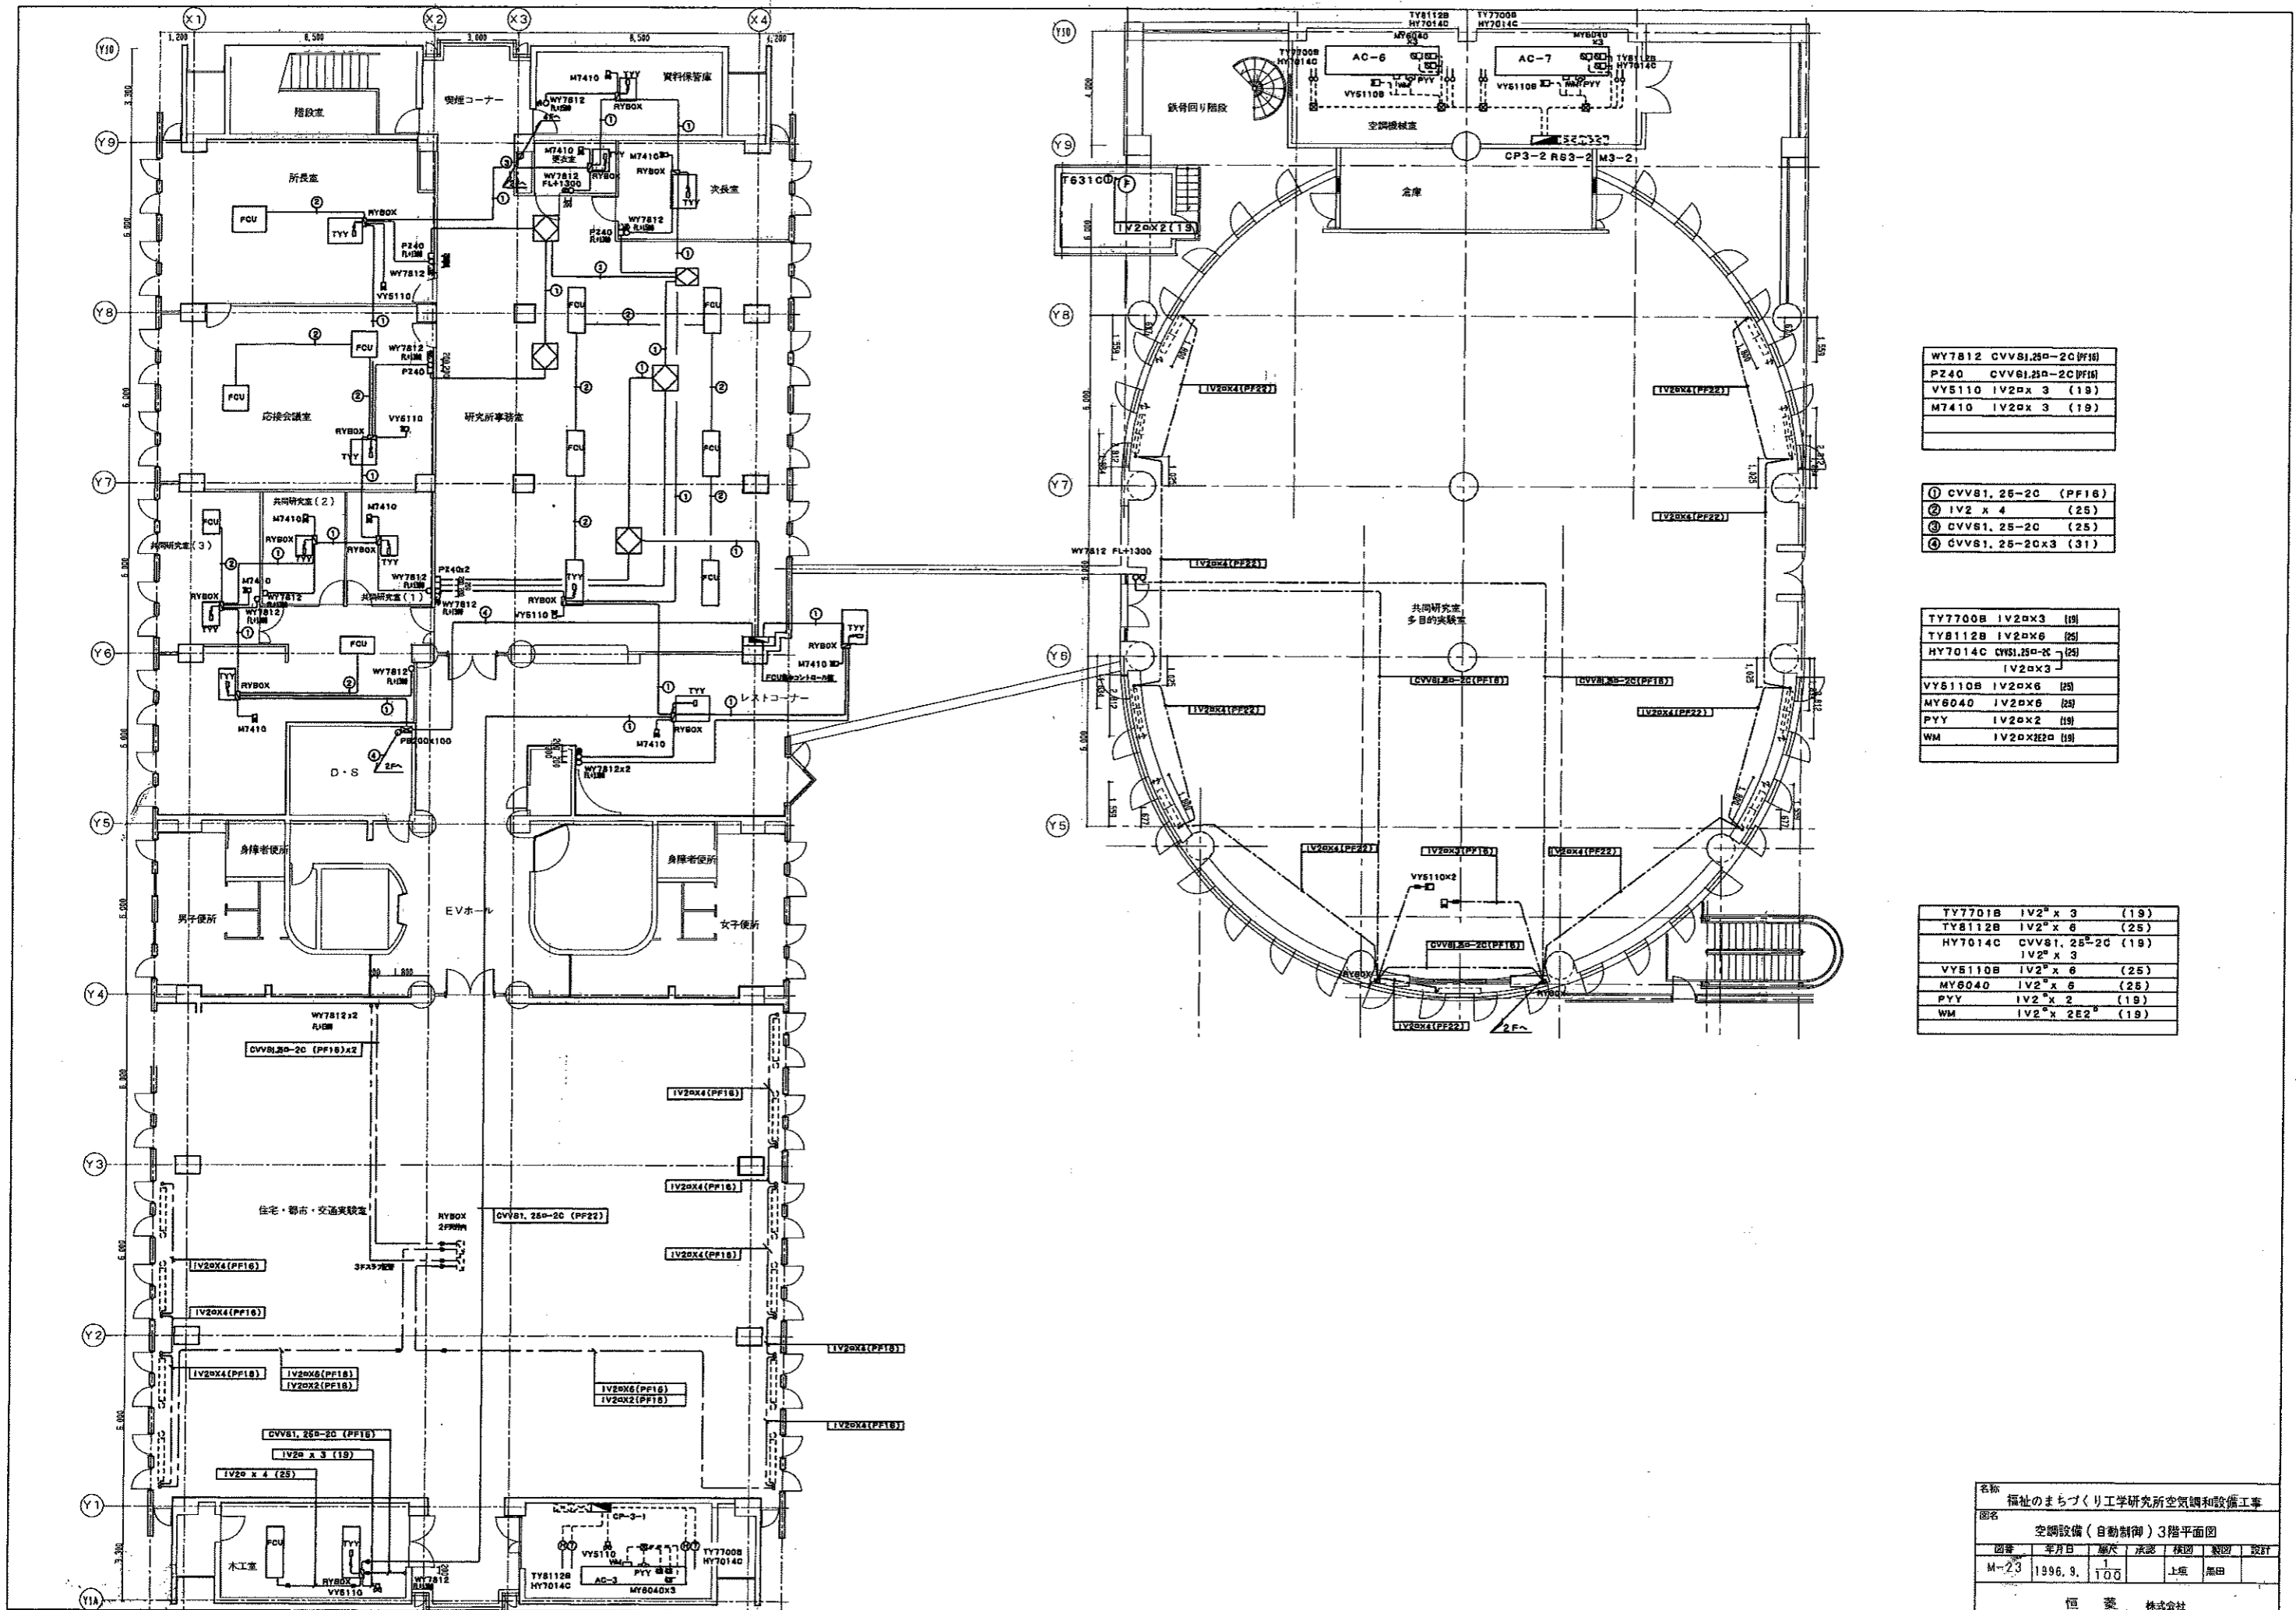

WY7812	CVV81.25P-2C(PF18)
PZ40	CVV61.25P-2C(PF18)
VY5110	IV2x3 (19)
M7410	IV2x3 (19)

- ① CVV81.25-2C (PF18)
- ② IV2 x 4 (25)
- ③ CVV61.25-2C (25)
- ④ CVV61.25-2Cx3 (31)

TY7700B	IV2x3 (19)
TY8112B	IV2x6 (25)
HY7014C	CVV81.25P-2C (25)
	IV2x3
VY5110B	IV2x6 (25)
MY6040	IV2x6 (25)
PYY	IV2x2 (19)
WM	IV2x2E2 (19)

TY7701B	IV2 <sup>2</sup> x3 (19)
TY8112B	IV2 <sup>2</sup> x6 (25)
HY7014C	CVV81.25P-2C (19)
	IV2 <sup>2</sup> x3
VY5110B	IV2 <sup>2</sup> x6 (25)
MY6040	IV2 <sup>2</sup> x6 (25)
PYY	IV2 <sup>2</sup> x2 (19)
WM	IV2 <sup>2</sup> x2E2 (19)

名称	福社のまちづくり工学研究所空調設備工事				
図名	空調設備(自動制御)3階平面図				
図種	年月日	縮尺	承認	検図	製図
M-23	1996.9.	1/100		上塚	黒田
恒 菱 株式会社					